

CDB - PROJECT NUMBER 805 - 030 - 019


**CONSTRUCT INNOVATION CENTER -
ACADEMIC BUILDING**
ILLINOIS MATH & SCIENCE ACADEMY
1500 SULLIVAN ROAD
AURORA, IL 60506

FOR:
STATE OF ILLINOIS
CAPITAL DEVELOPMENT BOARD


USING AGENCY:
ILLINOIS MATH & SCIENCE
ACADEMY

BY:
CORDOGAN CLARK & ASSOCIATES, INC.
960 RIDGEWAY AVENUE
AURORA, ILLINOIS 60506
630.896.4678

M/E/P/FP CONSULTANT:
RTM ENGINEERING CONSULTANTS
3 EXECUTIVE COURT, UNIT 4
SOUTH BARRINGTON, IL 60010
847.756.4180

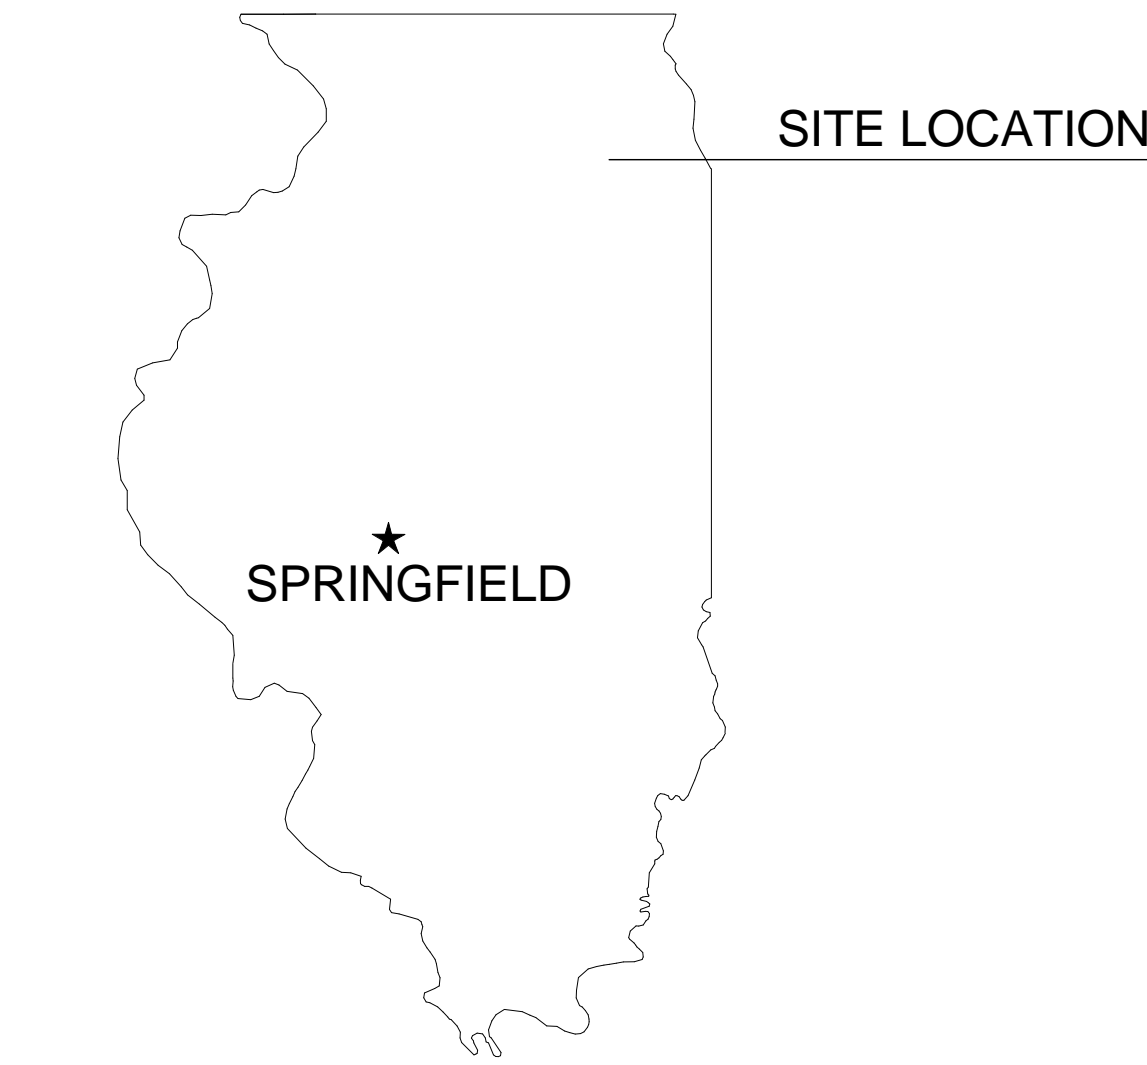

STATE LOCATION PLAN

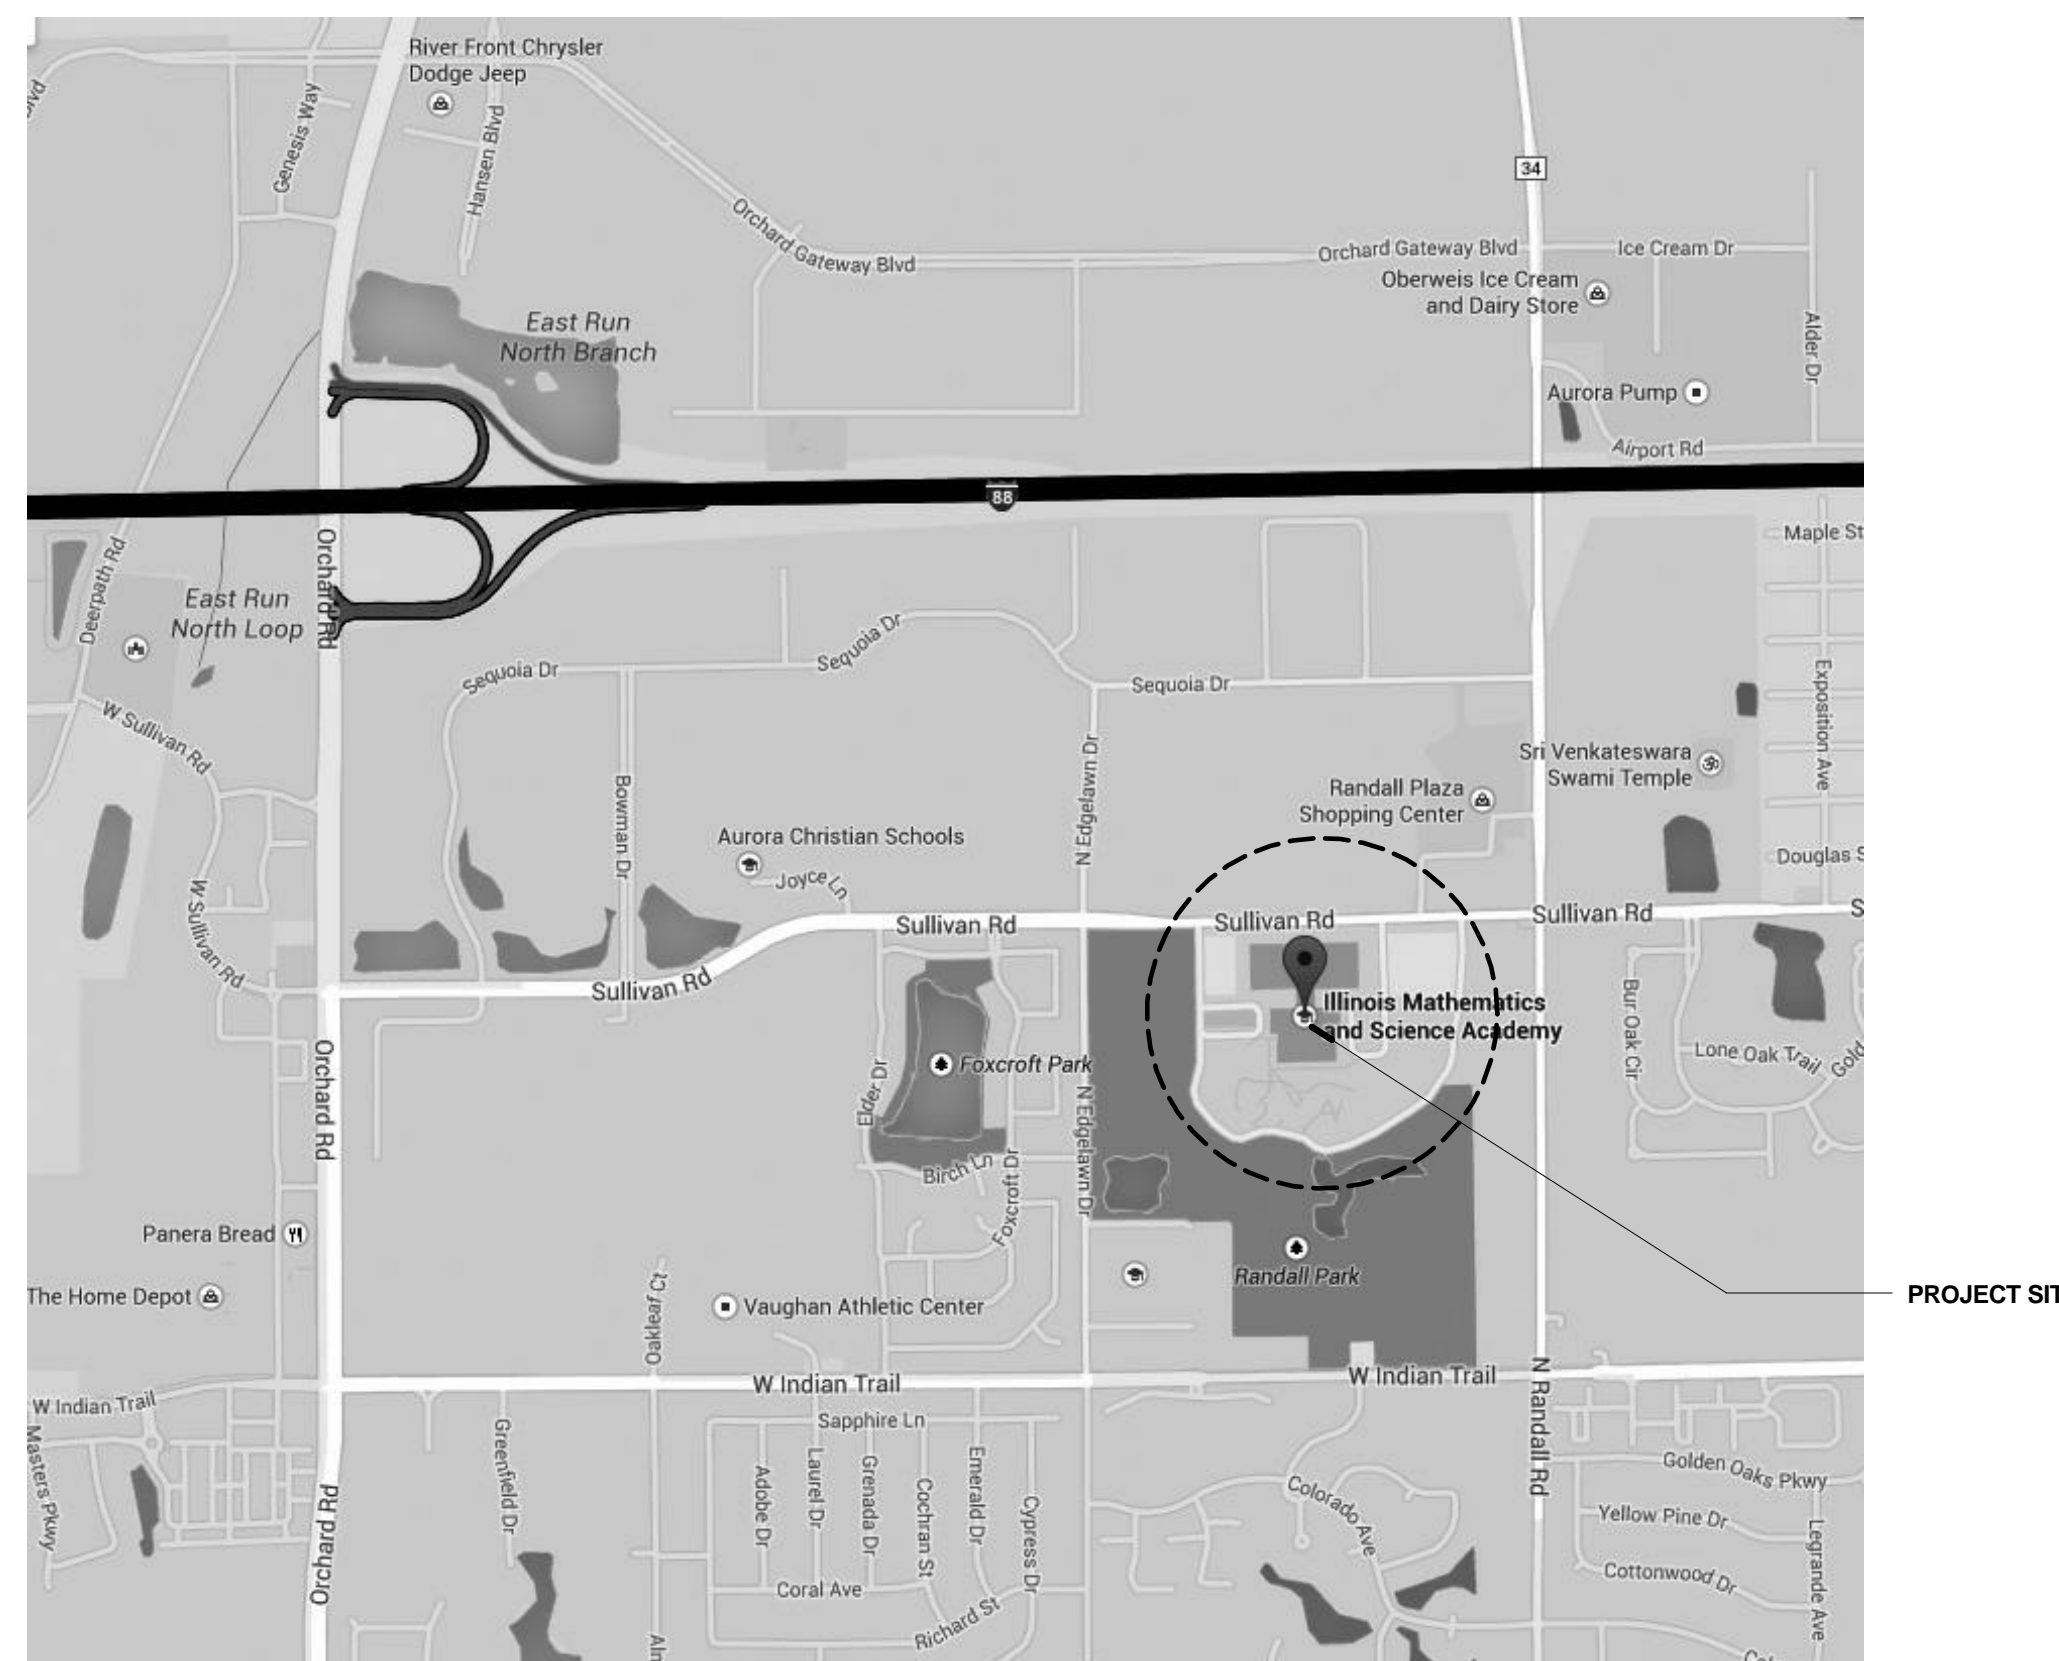

AREA LOCATION PLAN

INDEX OF DRAWINGS

- G1.1 TITLE SHEET & LOCATION PLANS
- G1.2 GENERAL NOTES & ABBREVIATIONS
- G2.1 LIFE SAFETY PLAN
- ARCHITECTURAL**
- D1.1 DEMOLITION PLANS
- D1.2 DEMOLITION PLANS
- D1.3 DEMOLITION DETAILS
- A1.1 ARCHITECTURAL SITE PLAN
- A1.2 ARCHITECTURAL SITE PLAN
- A2.1 FLOOR PLANS
- A2.2 FLOOR PLAN DETAILS
- A3.1 REFLECTED CEILING PLANS
- A3.2 REFLECTED CEILING DETAILS
- A4.1 ROOF PLANS
- A5.1 EXTERIOR BUILDING ELEVATIONS
- A6.1 BUILDING SECTIONS
- A6.2 BUILDING SECTIONS
- A6.3 DETAIL SECTIONS
- A6.4 DETAIL SECTIONS
- A6.5 DETAIL SECTIONS
- A7.1 ENLARGED FLOOR PLANS
- A7.2 MILLWORK DETAILS
- A8.1 INTERIOR ELEVATIONS
- A8.2 INTERIOR ELEVATIONS
- A9.1 DOOR SCHEDULE, ELEVATIONS, & DETAILS
- A9.2 GLAZING ELEVATIONS
- A10.1 ROOM FINISH SCHEDULE & PLANS
- A10.2 FLOOR FINISH PLAN
- A11.1 FURNITURE PLAN
- STRUCTURAL**
- S1.0 STRUCTURAL GENERAL NOTES
- S1.1 STRUCTURAL GENERAL NOTES
- S2.1 DEMO, FOUNDATION, AND ROOF PLANS
- S3.1 TYPICAL SECTIONS AND DETAILS
- S4.1 SECTIONS AND DETAILS
- PLUMBING**
- P0.0 PLUMBING SYMBOLS, SCHEDULES, & NOTES
- PD1.0 DEMO PLAN - PLUMBING
- P1.0 FLOOR PLAN - PLUMBING
- HEATING & VENTILATING**
- HV0.0 GENERAL NOTES & SYMBOLS
- HV1.0 HEATING AND VENTILATION SCHEDULES
- VD1.0 DEMOLITION PLAN - VENTILATION
- V1.0 FLOOR PLAN - VENTILATION
- HD1.0 DEMOLITION PLAN - HEATING
- H1.0 FLOOR PLAN - HEATING
- FIRE PROTECTION**
- FP1.0 FLOOR PLAN - FIRE PROTECTION
- ELECTRICAL**
- ED0.0 GENERAL NOTES & SYMBOL LIST
- ED1.0 DEMOLITION PLAN - POWER & SIGNAL
- ED2.0 DEMOLITION PLAN - LIGHTING
- ED2.1 DEMOLITION SITE PLAN - LIGHTING
- E1.0 FLOOR PLAN - POWER & SIGNAL
- E2.0 FLOOR PLAN - LIGHTING
- E3.0 SCHEDULES & SINGLE LINE DIAGRAM
- FIRE ALARM**
- FA1.0 FLOOR PLAN - FIRE ALARM

HATCH LEGEND	
SYMBOL	MATERIAL TYPE
[Hatch pattern]	CONCRETE
[Hatch pattern]	EXISTING WALL
[Hatch pattern]	GYPSUM BOARD
[Hatch pattern]	CONCRETE MASONRY UNIT
[Hatch pattern]	PLYWOOD
[Hatch pattern]	METAL
[Hatch pattern]	GLAZING
[Hatch pattern]	RIGID INSULATION
[Hatch pattern]	BATT INSULATION

LINETYPE LEGEND	
[Line style]	2 HOUR RATED FIRE WALL
[Line style]	CENTERLINE
[Line style]	HIDDEN LINE
[Line style]	THIN LINES
[Line style]	MEDIUM LINES
[Line style]	OUTLINES

NOTE: CONTRACTOR SHALL OBTAIN AND VERIFY ALL DIMENSIONS AND CONDITIONS AT JOB SITE AND BE FULLY RESPONSIBLE FOR SAME.

101% DESIGN SUBMITTAL

REVISIONS			CCA PROJ. #:	PREPARED	OFF.	ARCHITECTS • ENGINEERS •	www.cordoganclark.com		State of Illinois Bruce Rauner, Governor Illinois Capital Development Board	TITLE SHEET & LOCATION PLANS		CDB PROJECT NO.
NO.	DATE	REMARKS	14357	DRAWN	APPROVED					CONSTRUCT INNOVATION CENTER - ACADEMIC BUILDING	805-030-019	
				SSB / MT						CONSTRUCT INNOVATION CENTER - ACADEMIC BUILDING	DATE	6/2/2015
				CHECKED	APPROVED					ILLINOIS MATH & SCIENCE ACADEMY	SHEET NO.	G1.1
				BC						1500 SULLIVAN ROAD		
										AURORA, IL 60506		
												BUILDING #CP078

6/3/2015 2:46:16 PM